

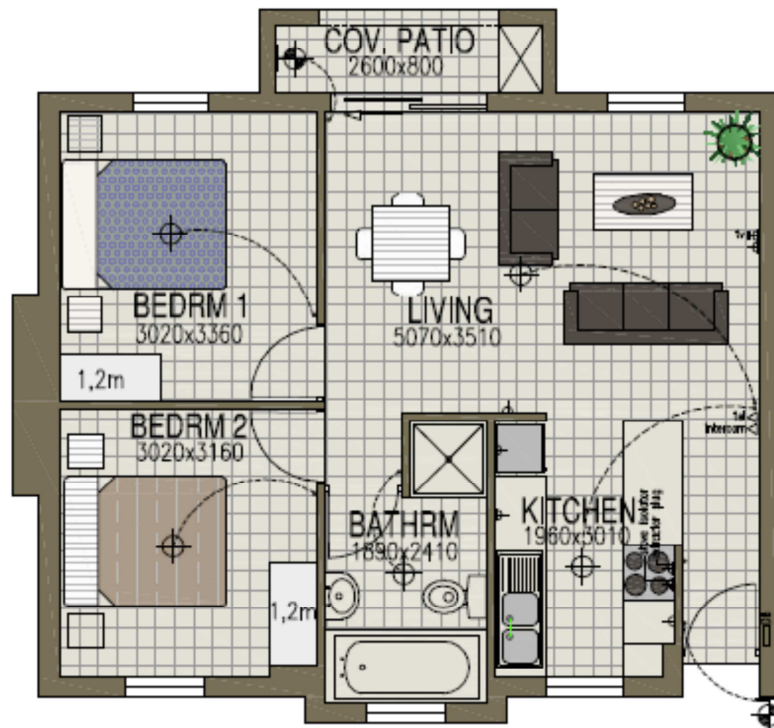


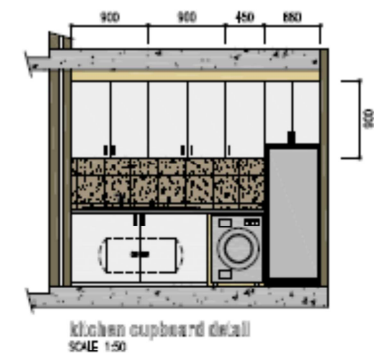

UNIT TYPE 1 (65 Sq/M)
SCALE 1:50

PROJECT:
PROPOSED MARKETING
FOR SELLESA DEVELOPERS ON
ERF 139 BURGANDY ESTATE

ELECTRICAL LEGEND	
Light switch	⊕
Ceiling mounted light	⊕
Watertight wall mounted light	⊕
Distribution board	⊕
Single power point	⊕
Double power point	⊕
Stove point	⊕
Hot water cylinder	⊕
Telephone point	⊕

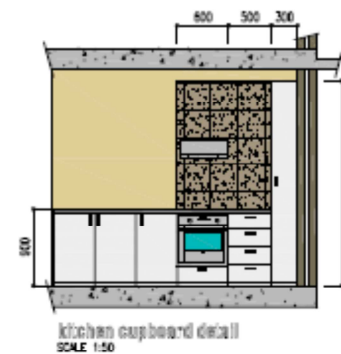

NOTES:
-Floor tiles throughout unit
-Tiles skirtings throughout units
-single curtain rail to all windows



PO: Box 20147 — Big Bay — 7448
Tel: (021) 5544294 — Fax: (021) 5542598 — Cell: 082 4936754
WEB: www.ghad.co.za — Email: graham@ghad.co.za

DATE : 27/09/2013	SCALE: 1:50	REVISION : 1.1
SHEET : 1 OF 1		DRAWING No : 12-79