

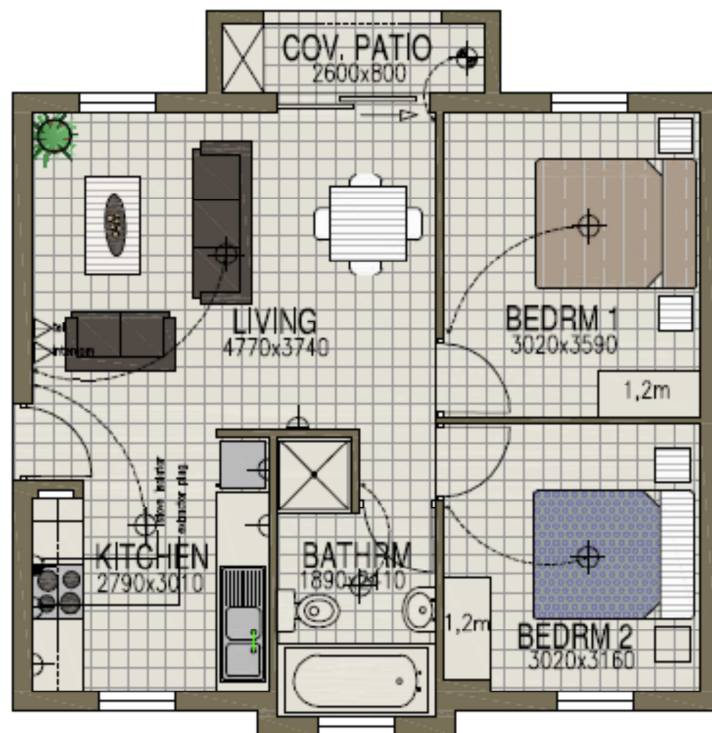


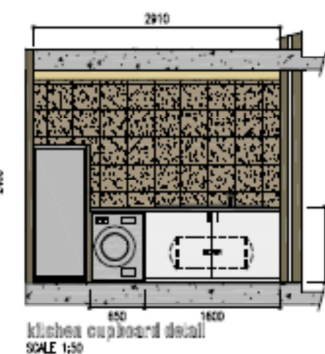

UNIT TYPE 2 (65 Sq/M)
SCALE 1:50

PROJECT:
PROPOSED MARKETING
FOR SELLESA DEVELOPERS ON
ERF 139 BURGANDY ESTATE

ELECTRICAL LEGEND	
Light switch	•
Ceiling mounted light	⊕
Watertight wall mounted light	⊕
Distribution board	□ DB
Single power point	⌚
Double power point	⌚
Stove point	⌚
Hot water cylinder	⊗ HWC
T.V. point	⌚ tv
Telephone point	⌚ tel

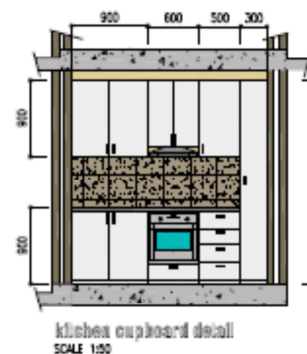

NOTES:
-Floor tiles throughout unit
-Tiles skirtings throughout units
-single curtain rail to all windows



PO: Box 20147 - Big Bay - 7448
Tel: (021) 5544294 - Fax: (021) 5542898 - Cell: 082 4936754
Web: www.glad.co.za - Email: graham@glad.co.za

DATE :	SCALE :	REVISION :
27/09/2013	1:50	1,1
SHEET :		DRAWING No :
1 OF 1		12-79